 



THE INFORMATION AND DESIGNS CONTAINED IN THIS DRAWING ARE CONFIDENTIAL AND THE PROPRIETARY PROPERTY OF PACIFIC MOBILE STRUCTURES. NEITHER THIS DESIGN NOR ANY INFORMATION CONTAINED IN THIS DRAWING MAY BE REPRODUCED OR DISCLOSED TO OTHERS WITHOUT THE EXPRESS WRITTEN CONSENT OF PACIFIC MOBILE STRUCTURES.

INTERIOR DIMENSIONS ARE FROM FINISH TO FINISH. ALL FURNITURE/EQUIPMENT IS SHOWN FOR REFERENCE ONLY AND TO BE PROVIDED BY OTHERS.

IM ICE MAKER FOR FRIDGE

COLD WATER STUB OUT
EXACT LOCATION TBD

 FULL HEIGHT WALLS - STC 49 RATING

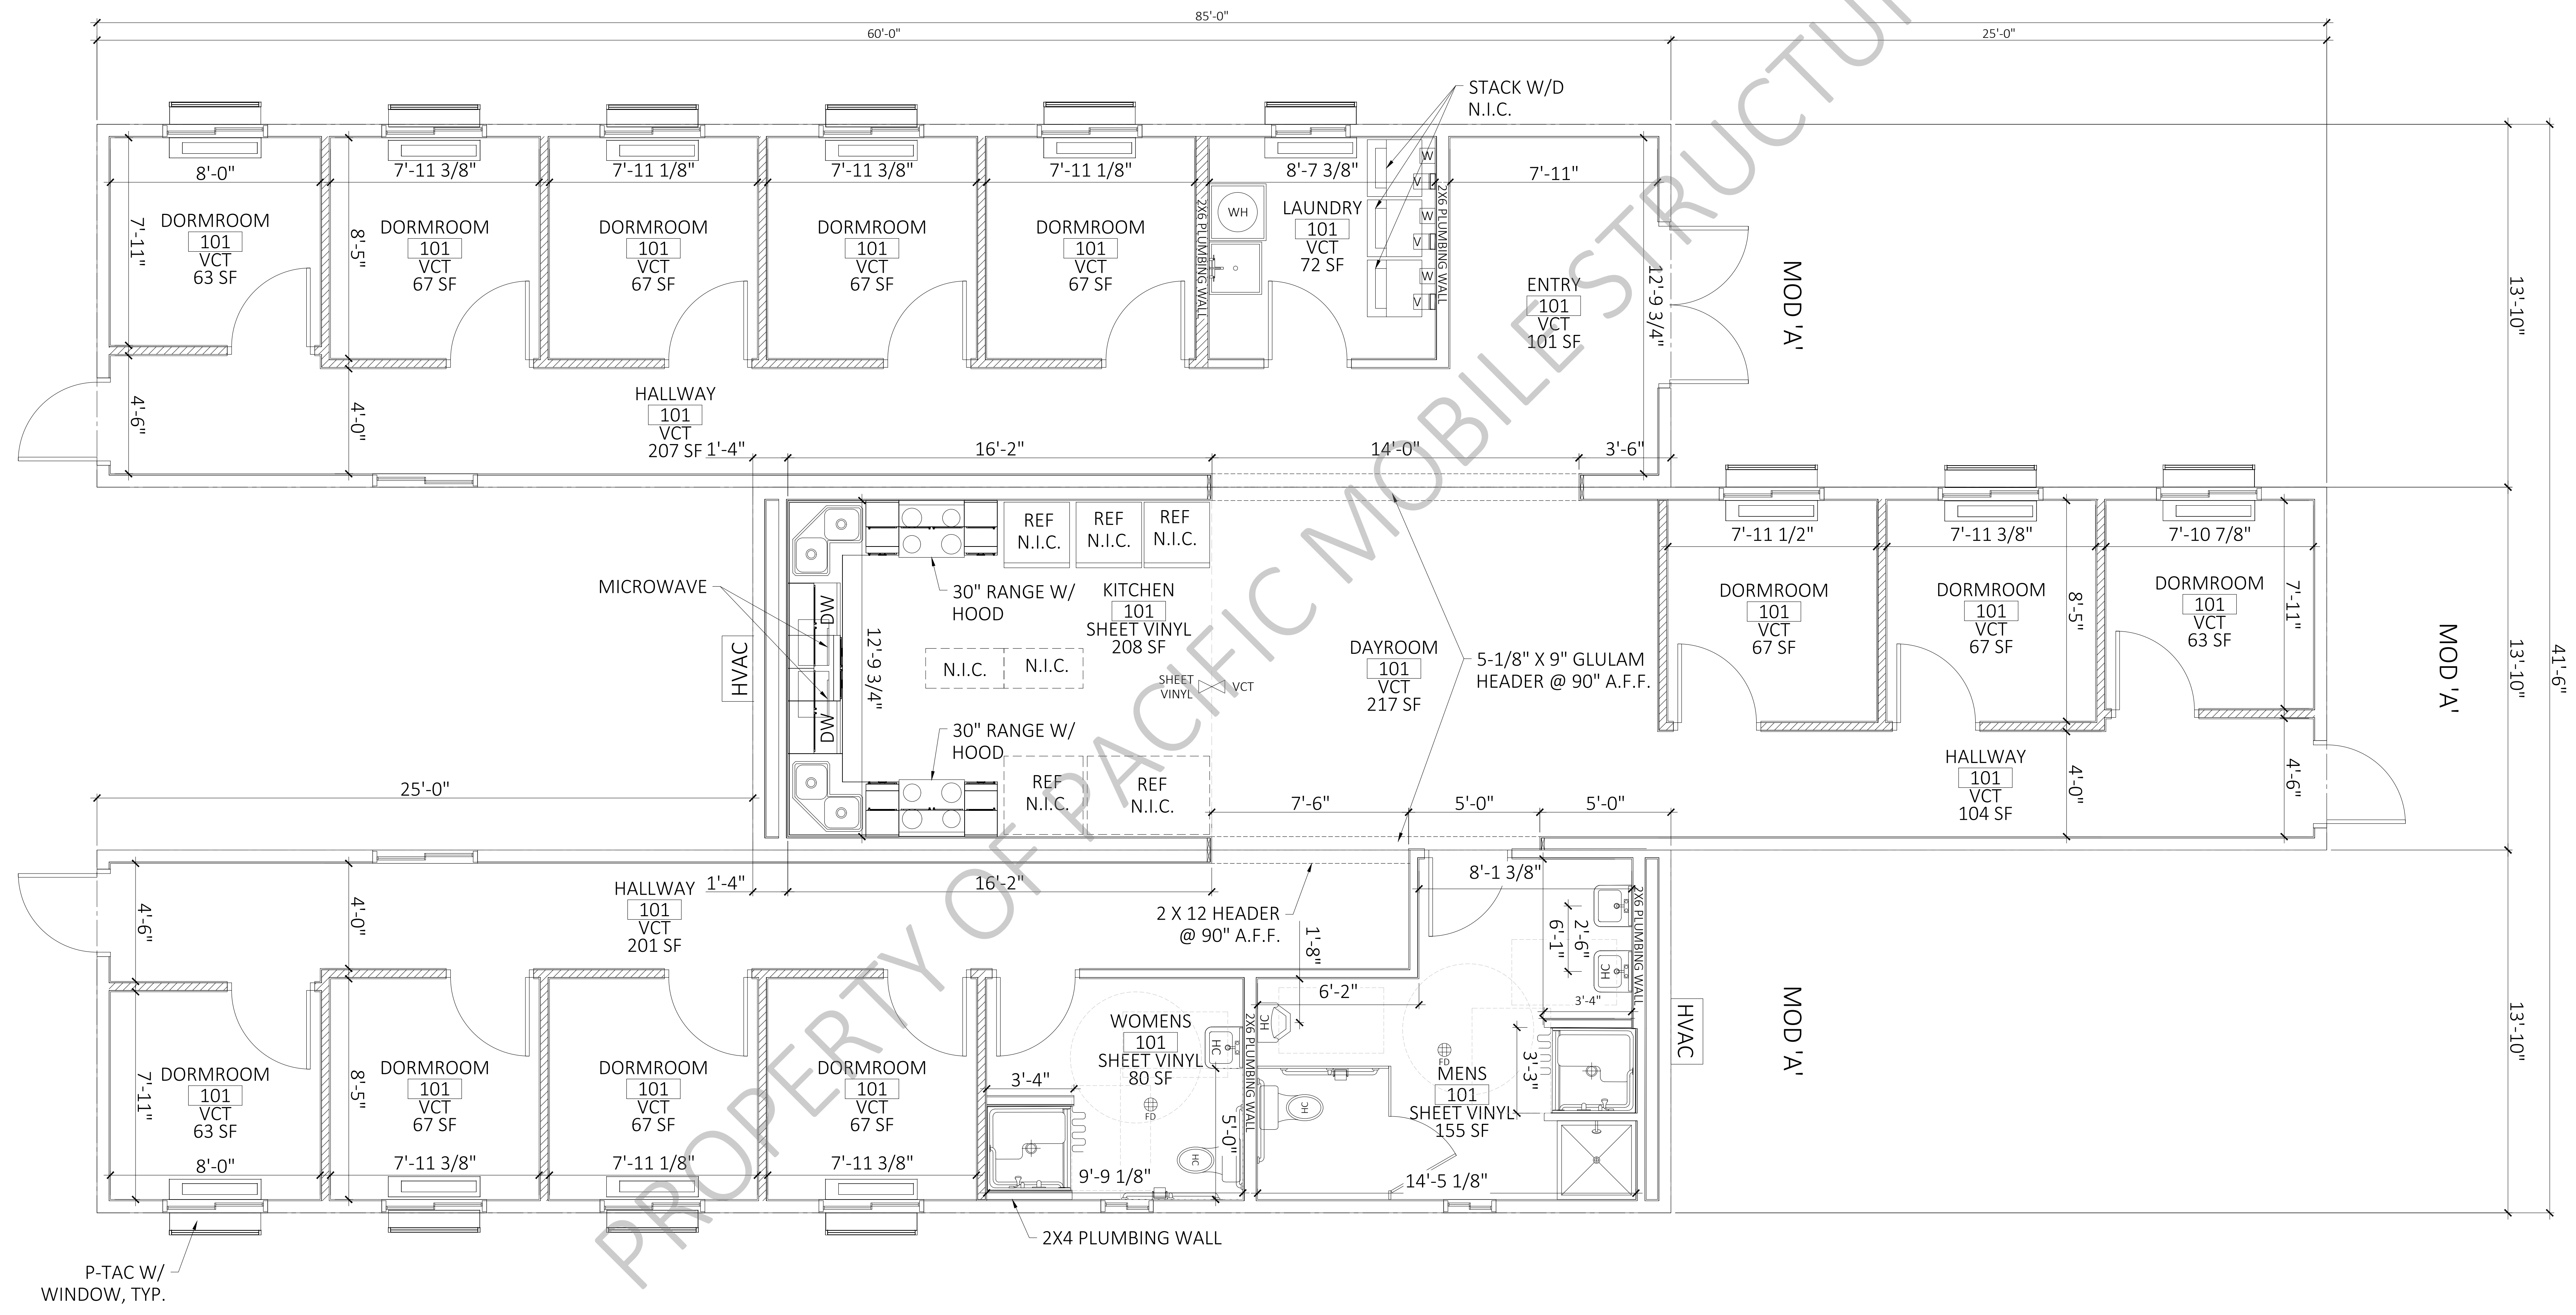

REVISION
1.
2.
3.
4.

301870 - 42X60 CHEHALIS

LOCATION: TBD
JOB NO: UNIT 301870
SCALE: 3/8" = 1'-0"
DRAWN BY: LK
DATE: 03-05-2026

FLOOR PLAN

A-2

